



Faith Group



ISSUE FOR BID

**SAN ANTONIO INTERNATIONAL AIRPORT
EVID SYSTEM
UPGRADE
9800 AIRPORT BLVD.
SAN ANTONIO, TX 78216**

KEYED NOTES

(THIS SHEET ONLY)

- 1 REMOVE EXISTING DISPLAY AND DDC. REPLACE WITH NEW MONITOR AND DDC. USE EXISTING MOUNT FOR NEW DISPLAY. SECURE DDC TO BACK OF MONITOR. USE CABLE MANAGEMENT AS NECESSARY TO PROVIDE CLEAN WORKMANSHIP.
- 2 REMOVE EXISTING DISPLAY, DDC AND MONITOR MOUNT. REPLACE WITH NEW MONITOR, DDC AND MOUNT. SECURE DDC TO BACK OF MONITOR. USE CABLE MANAGEMENT AS NECESSARY TO PROVIDE CLEAN WORKMANSHIP.

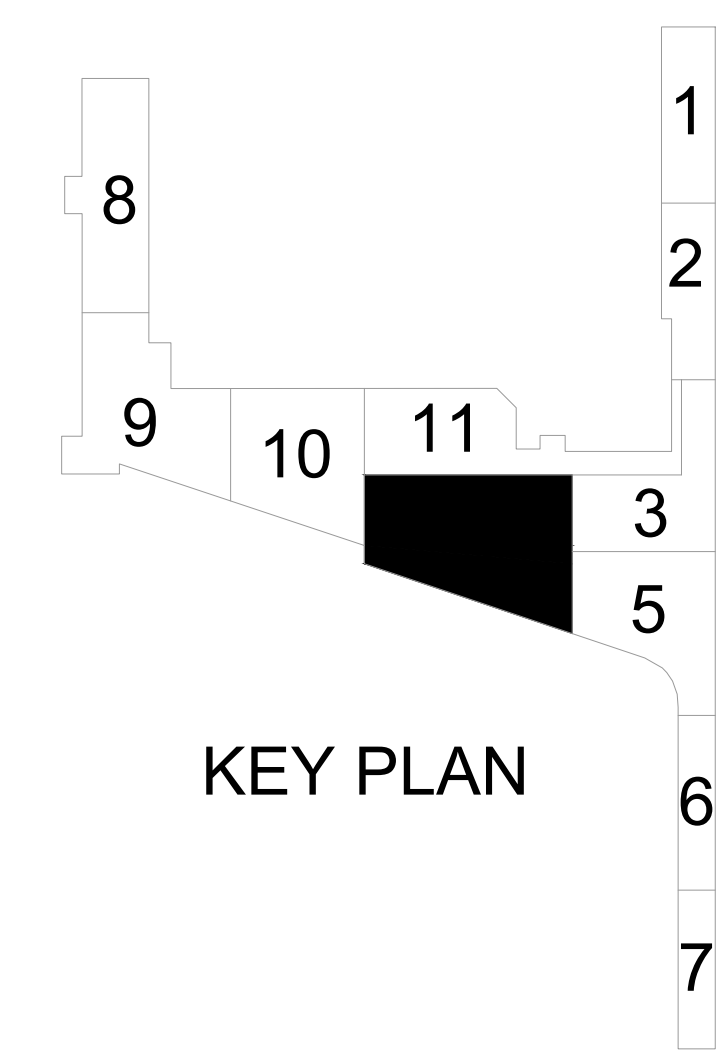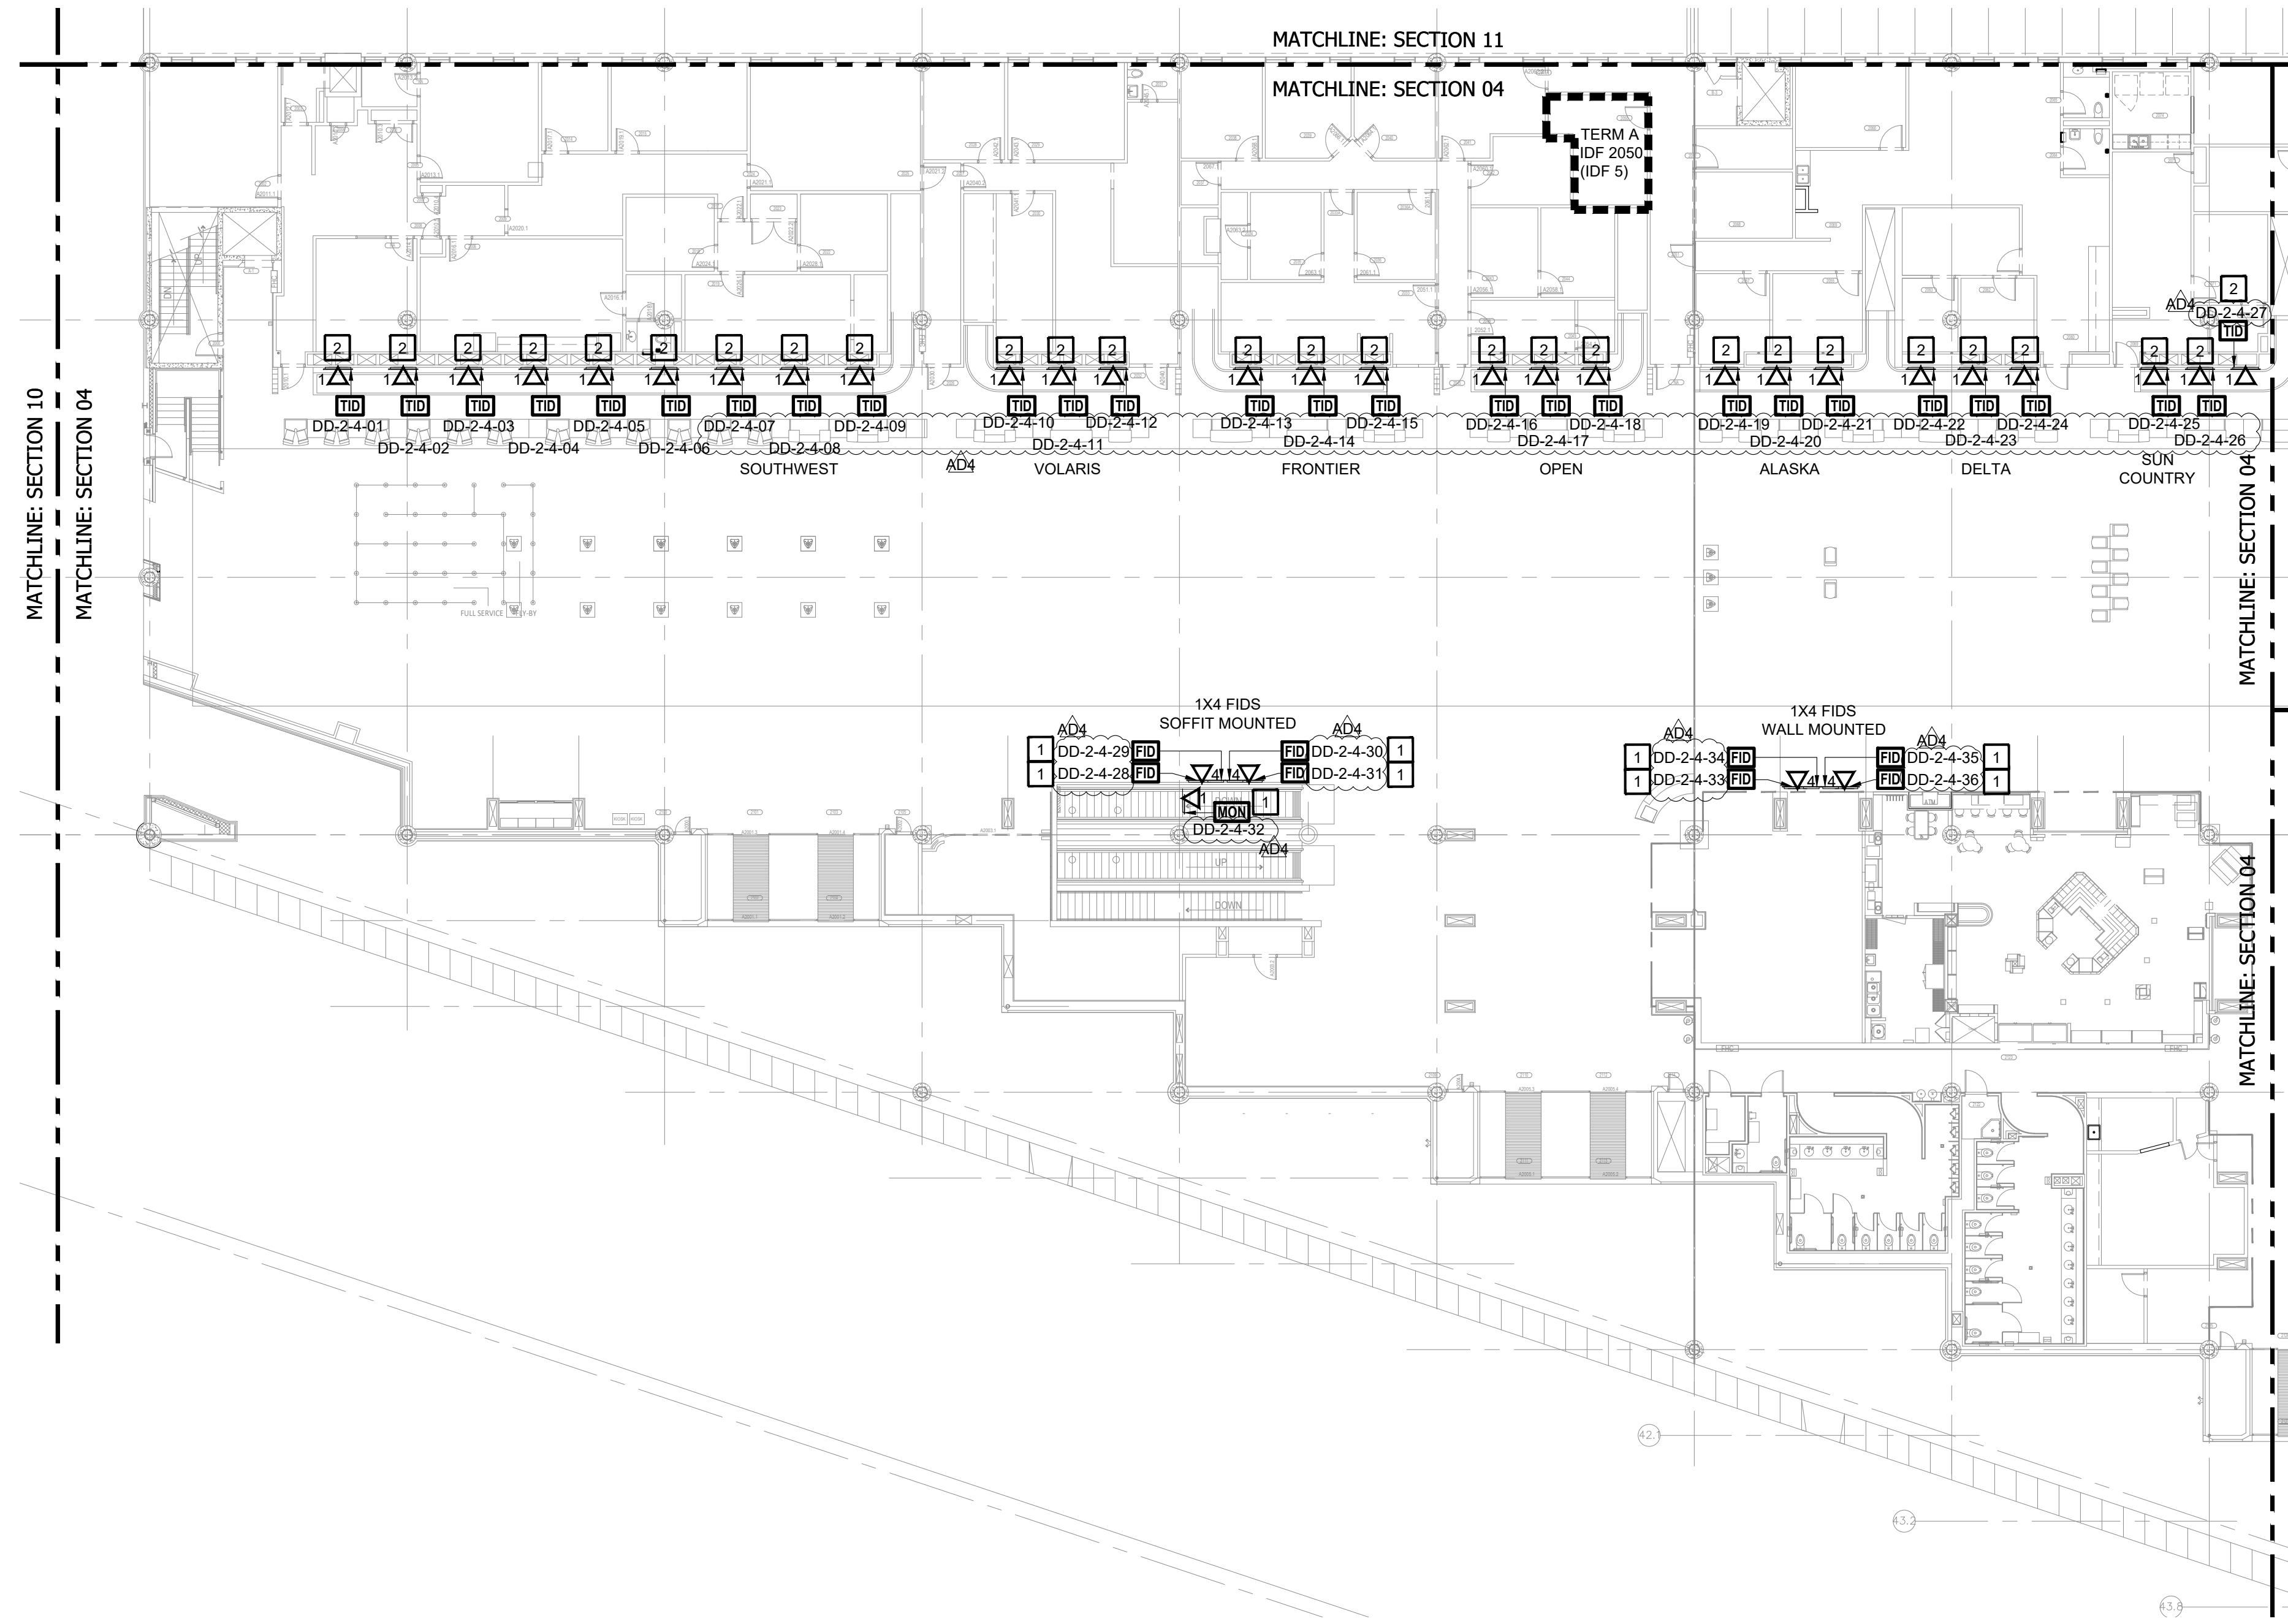

1
EVIDS PLAN
TERMINAL A DEPARTURE LEVEL AREA 04
0 8' 16' 32'

REVISIONS:	DATE:	
ADDENDUM #4	07/22/2021	
SHEET TITLE:		
EVIDS PLAN TERMINAL A DEPARTURE LEVEL AREA 04		
SHEET		
AV.2.2.04		
DATE:	04/26/2021	
DRAWN	DESIGNED	CHECKED
DM	BS	BS